


FILE PATH: Autodesk Docs/24-01977 Troup County Georgia Fire Station/Troup Co FS Prototype R24.DD.v1
PRINTED: 9/30/2024 3:43:19 PM



PROJECT
NORTH

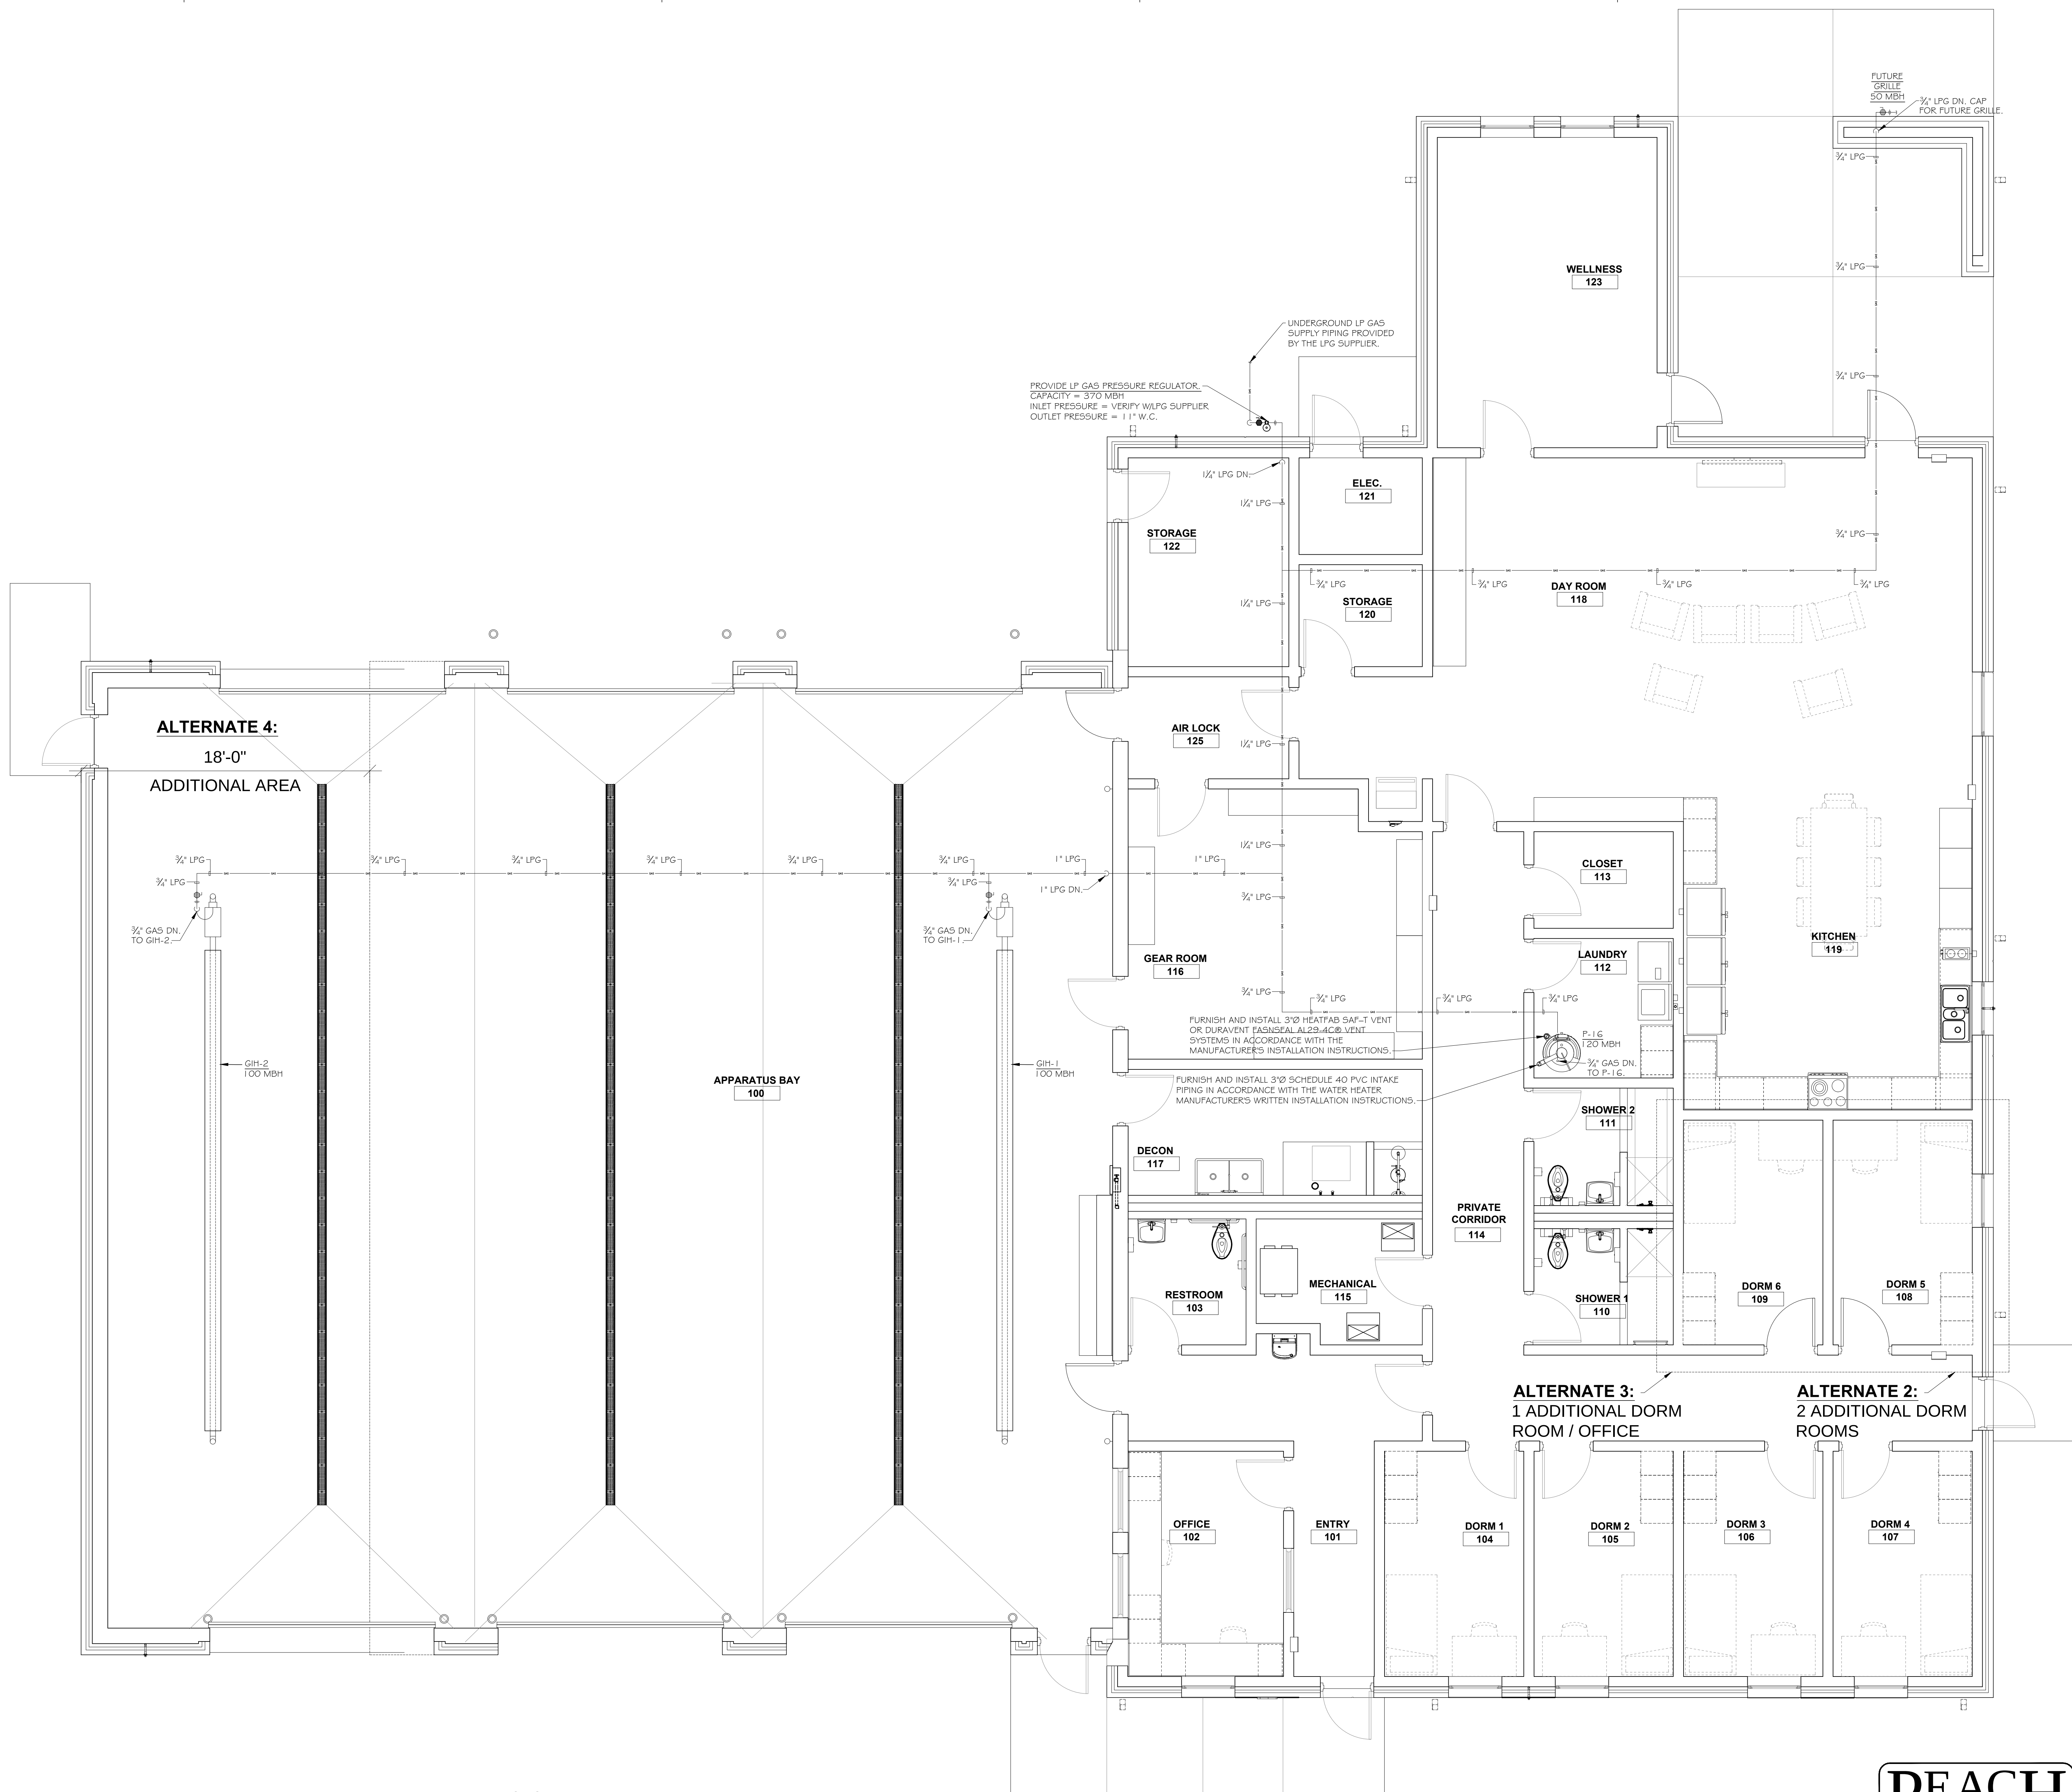

1
P1.5

ALTERNATE FLOOR PLAN - PLUMBING - LP GAS PIPING

SCALE: 1/4" = 1'-0"

PEACH
Engineering
1214 1st Avenue Suite 210
Columbus, GA 31902
(706) 596-1840
Fax: (706) 596-9233

2WR

urban-gro

11 Ninth Street, Suite 120
Columbus, GA 31901
P. (706) 571-6923



**NOT FOR
CONSTRUCTION**

IMPORTANT NOTICE: This document is confidential. Do not reproduce this document in any way other than what is needed to perform within the scope of your work. Return this document to 2WR + Partners upon completion of your work or destroy. Delete electronic copies from your system once work is completed.

This document, and any affiliated design, construction, security, and planning documents ("Affiliated Documents") are confidential and contain proprietary data and information of the owner and 2WR + Partners. This document, and any affiliated documents, shall only be viewed/used by individuals and entities that have been explicitly authorized in writing by the owner and 2WR + Partners' nondisclosure agreement, and shall be viewed/used solely for the purpose stated in such authorization. Any copying, reproducing, modifying, distributing, displaying, or communicating the contents of these documents, by any means, is strictly prohibited.

**TROUP COUNTY FIRE STATION -
PROTOTYPE**

TROUP COUNTY
GEORGIA

CONSTRUCTION DOCUMENTS

Project No.: 24-01977
Date: 1/29/2025
Drawn by: WAS
Checked by: WAS
Revisions:

No.	Date	Description
1	10/22/2025	Gas Piping

**ALTERNATE
FLOOR PLAN -
PLUMBING - LP
GAS PIPING**

P1.5